




SITE LOCATION MAP
SCALE 1"= 200'

NOTE:
NATURAL DIVERSITY DATA BASE MAPS WERE
REVIEWED AND NO AREAS EXIST IN THE PROXIMITY.

SCOTTISH
RITE™

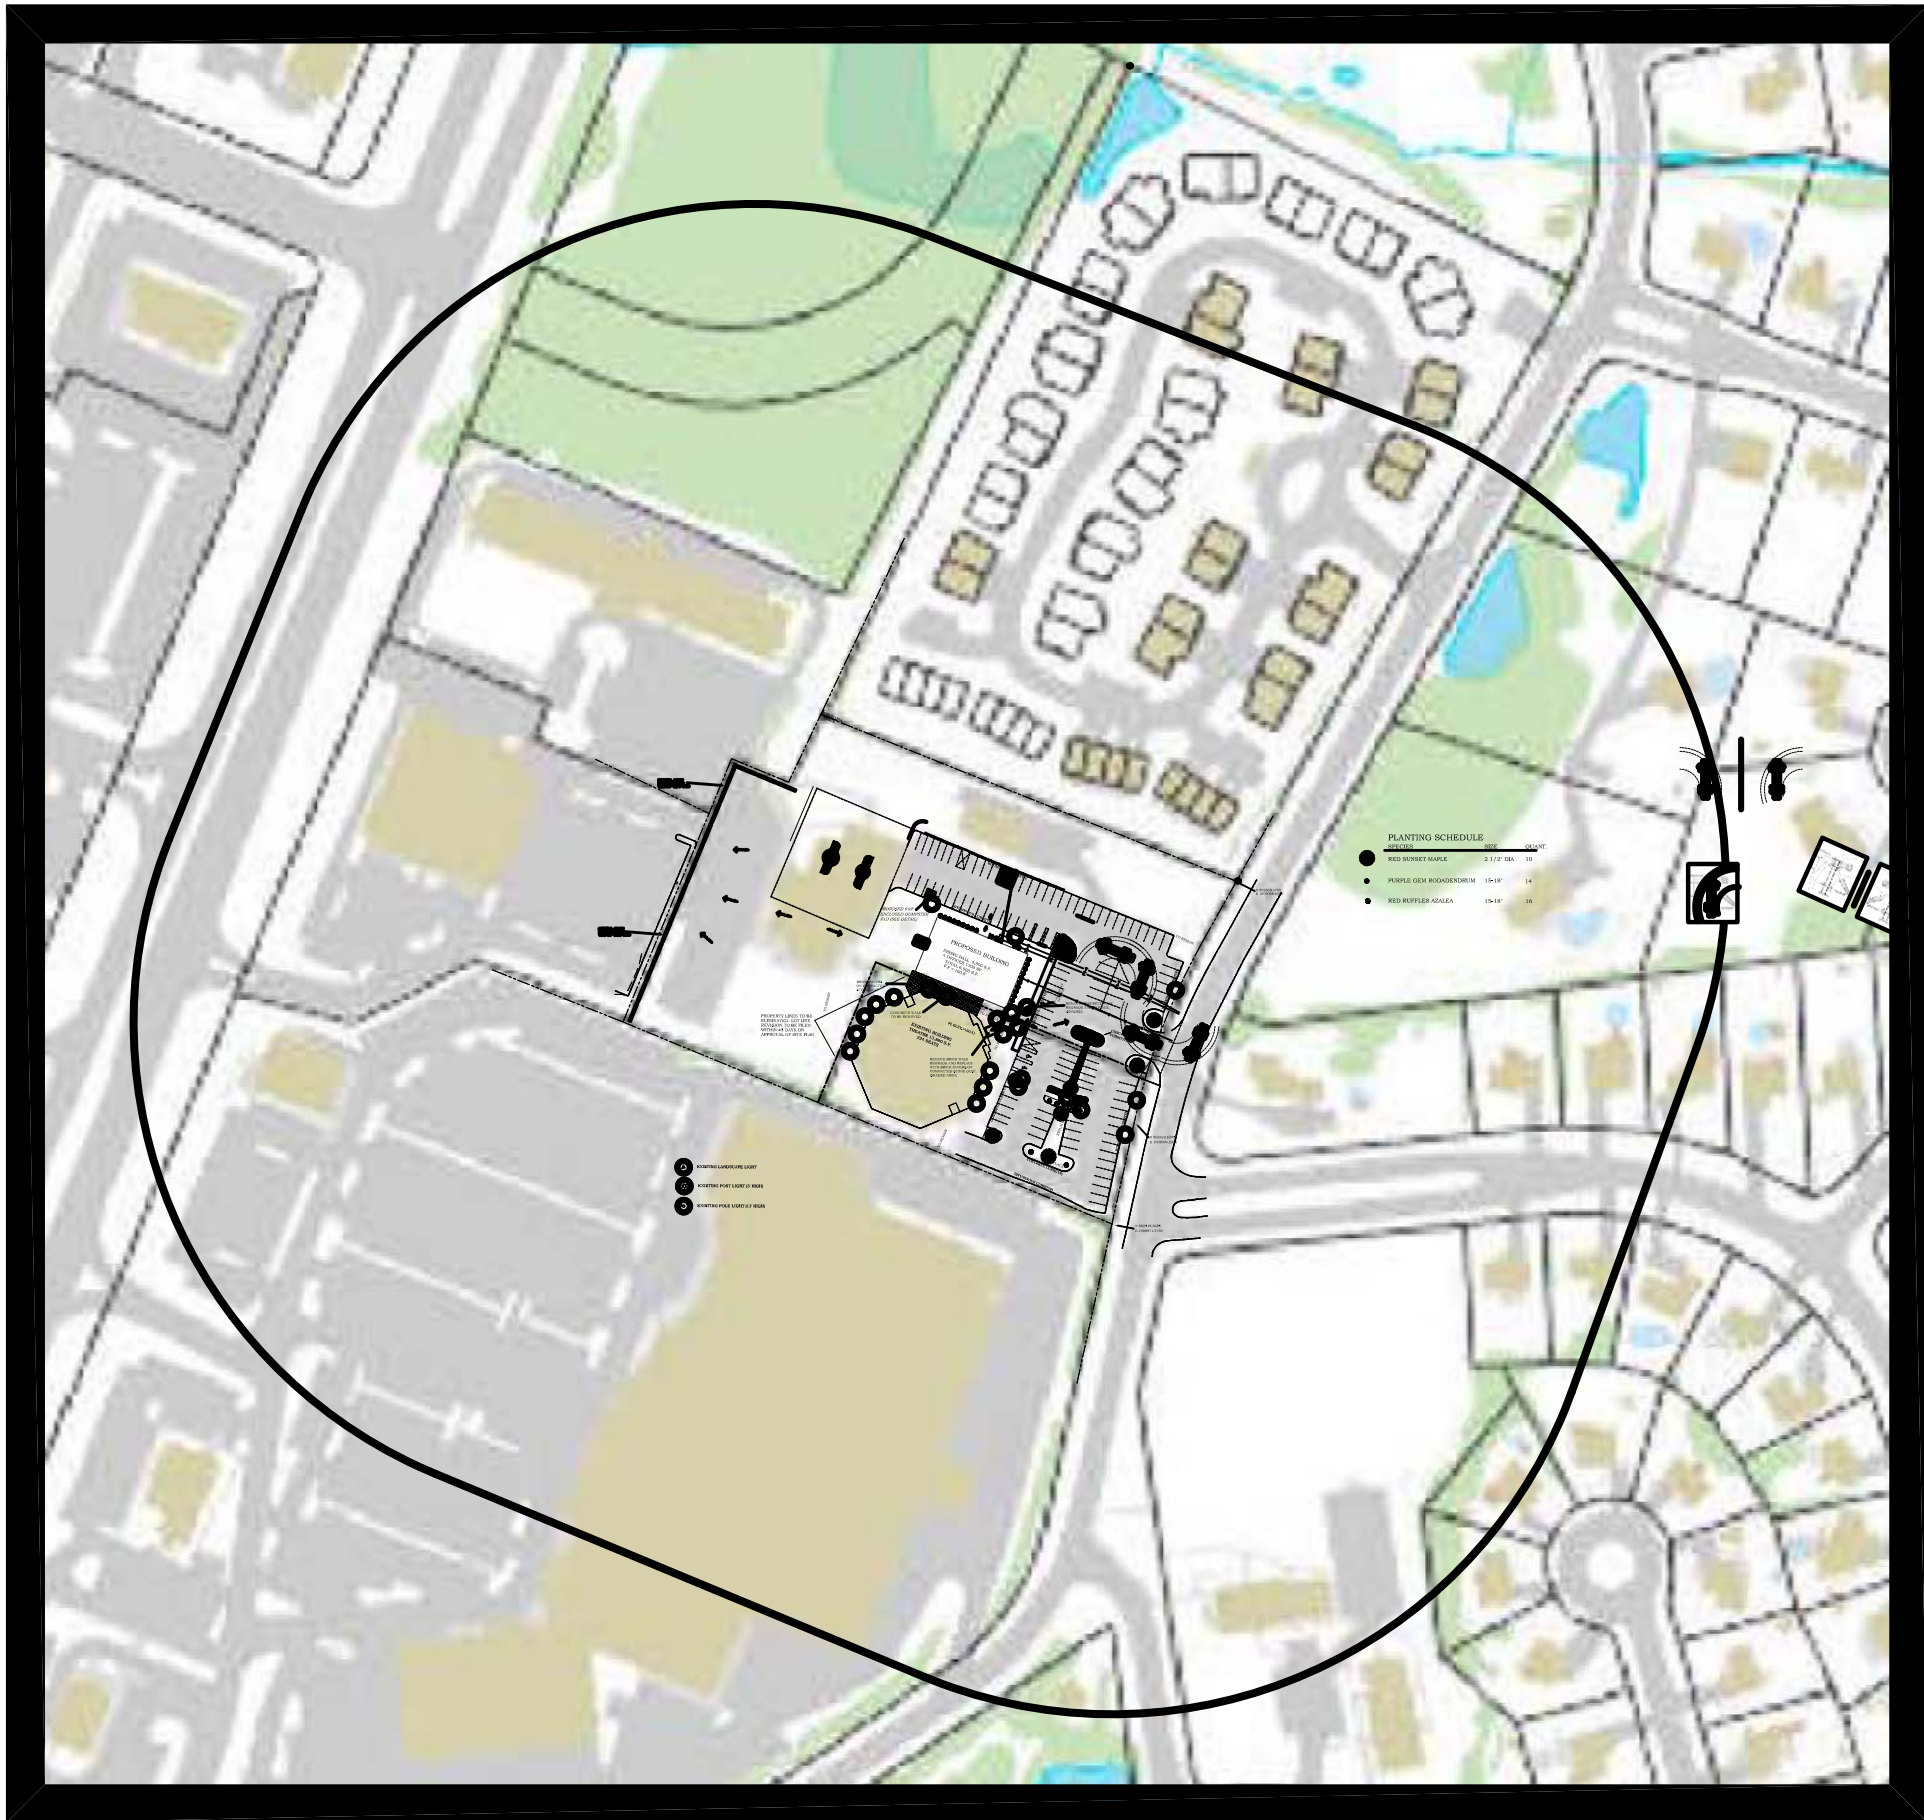

Valley of Hartford

SIGNATURE BLOCK

Approved by the Town Plan and Zoning Commission under

Petition # _____ at meeting of _____

Date Chairman

FILE NUMBER	SHEET NUMBER
223186	COVER

SCOTTISH RITE FOUNDATION OF HARTFORD, INC. PREPARED FOR #207 DEMING STREET NEWINGTON, CONNECTICUT	JONES ENGINEERING LLC	92 NORTH SUMMIT ST, SUITE 24 P.O. BOX 249 SOUTHINGTON, CT 06489	PHONE: (860) 621-0700 FAX: (860) 621-6066	REVISIONS:									
				DATE:	DATE:	DATE:	DATE:	DATE:	DATE:	DATE:	DATE:		
SCALE: NA		DATE:	1/12/2024	DRAWN BY:	RBB	CHECKED BY:	JEL						


Survey Notes:

1. This map has been prepared within the "Minimum Standards For Surveys and Maps in the State of Connecticut" as adapted for use by the regulations of Connecticut state agencies on September 26, 1996. (CT Sections 20-300b-20).
- Type Of Survey: Zoning Location Survey
-Boundary Determination Category: Resurvey
-Horizontal Accuracy Class: A-2/ NAD 83
-Topographic Survey: Class T-2/NAVD 88
2. Map References
- A. ORIGINAL SURVEY PROPERTY OF SPHINX SHRINERS
A.A.O.N.M.S. DEMING STREET, NEWINGTON, CONNECTICUT.
RESUBDIVISION PLAN, SHEET 1 OF 1, SCALE 1"=40', DATED:
06-01-10, REVISED 09-23-10, BY BGI THE BONGIOVANNI
GROUP, INC., LAND SURVEYORS, NEWINGTON,
CONNECTICUT.
- B. PROPERTY SURVEY, RESURVEY, MAP SHOWING LAND TO BE
ACQUIRED BY MORNINGSIDE LLC, 199 DEMING STREET,
NEWINGTON, CONNECTICUT, DATED: 10-12-10, LAST
REVISED 3-14-11, SCALE: 1"=40', SHEET 1 OF 1, BY BGI,
BONGIOVANNI GROUP, INC., LAND SURVEYORS,
NEWINGTON, CONNECTICUT.
3. Bearings are based upon Map Reference #2 A.
4. Physical Evidence of Underground Utilities as Located in Field.
All Underground Utilities Not Shown.
- THESE DRAWINGS ARE INSTRUMENTS OF PROFESSIONAL SERVICE OF
JONES ENGINEERING LLC, AND HAVE BEEN PREPARED SPECIFICALLY
FOR THE OWNER OF THIS PROJECT AT THIS SITE, AND ARE NOT
TO BE USED FOR ANY OTHER PURPOSE. LOCATION OR OWNER WITHOUT
WRITTEN CONSENT OF JONES ENGINEERING LLC.

LEGEND

- EX. PROPERTY LINE
EX. EASEMENT LINE
EX. FINS/MQNS
EX. E.D.P.
EX. WETLANDS
EX. WETLANDS BUFFER
EX. CONTOUR
EX. STREAM
EX. CHAIN LINK FENCE
EX. GUARD RAIL
EX. SANITARY SEWER
EX. STORM SEWER
EX. UTILITY POLE
EX. LIGHT POLE (SINGLE)
EX. SANITARY CLEAN DUT
EX. BOLLARD
EX. GAS VALVE
EX. WATER VALVE
EX. TREELINE
EX. TREE

Zoning Information
Zone PD

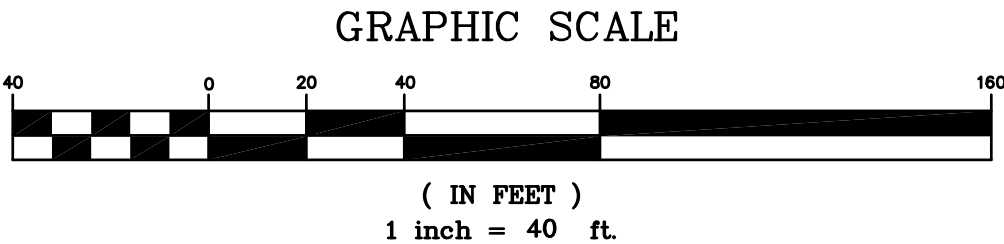

Know what's below.
Call before you dig.

TO MY KNOWLEDGE AND BELIEF, THIS MAP IS
SUBSTANTIALLY CORRECT AS NOTED HEREON.

NOT VALID UNLESS
EMBOSSSED SEAL IS
PRESENT
JONES
JAMES E. JONES CT. L.S. REG. NO. 12329

REVISIONS:	DATE: 12/27/2024
DATE:	DATE:
DATE:	DATE:
DATE:	DATE:
DATE:	DATE:
DATE:	DATE:

JONES
ENGINEERING LLC
CIVIL ENGINEERING & LAND SURVEYING

92 NORTH SUMMIT ST, SUITE 2A
P.O. BOX 249
SOUTHINGTON, CT 06489

PHONE: (860) 621-0700
FAX: (860) 621-6066

EXISTING CONDITIONS SURVEY
SCALE: 1" = 40'

PREPARED FOR
SCOTTISH RITE FOUNDATION
OF HARTFORD INC

DATE: 11/12/2024
DRAWN BY: RBB
CHECKED BY: JEL

#207 DEMING STREET
NEWINGTON, CONNECTICUT

JONES
ENGINEERING LLC

FILE NUMBER	SHEET NUMBER
223186	EXCOND 1


THESE DRAWINGS ARE INSTRUMENTS OF PROFESSIONAL SERVICE OF JONES ENGINEERING LLC, AND HAVE BEEN PREPARED SPECIFICALLY FOR THE OWNER OF THIS PROJECT AT THIS SITE, AND ARE NOT TO BE USED FOR ANY OTHER PURPOSE, LOCATION OR OWNER WITHOUT WRITTEN CONSENT OF JONES ENGINEERING LLC.

LEGEND

EXISTING

PROPOSED

PROPERTY LINE	---	---
EASEMENT LINE	---	---
PINS/MINS	● ■	● ■
E.O.P.	---	---
WETLANDS	---	---
WETLANDS BUFFER	---	---
CONTOUR	100	100
STREAM	---	---
CHAIN LINK FENCE	---	---
GUARD RAIL	---	---
SANITARY SEWER	S	S
STDRN SEWER	---	---
UTILITY POLE	---	---
LIGHT POLE	---	---
SANITARY CLEAN OUT	---	---
BOLLARD	●	●
GAS VALVE	---	---
WATER VALVE	---	---
TREELINE	---	---
TREE	---	---

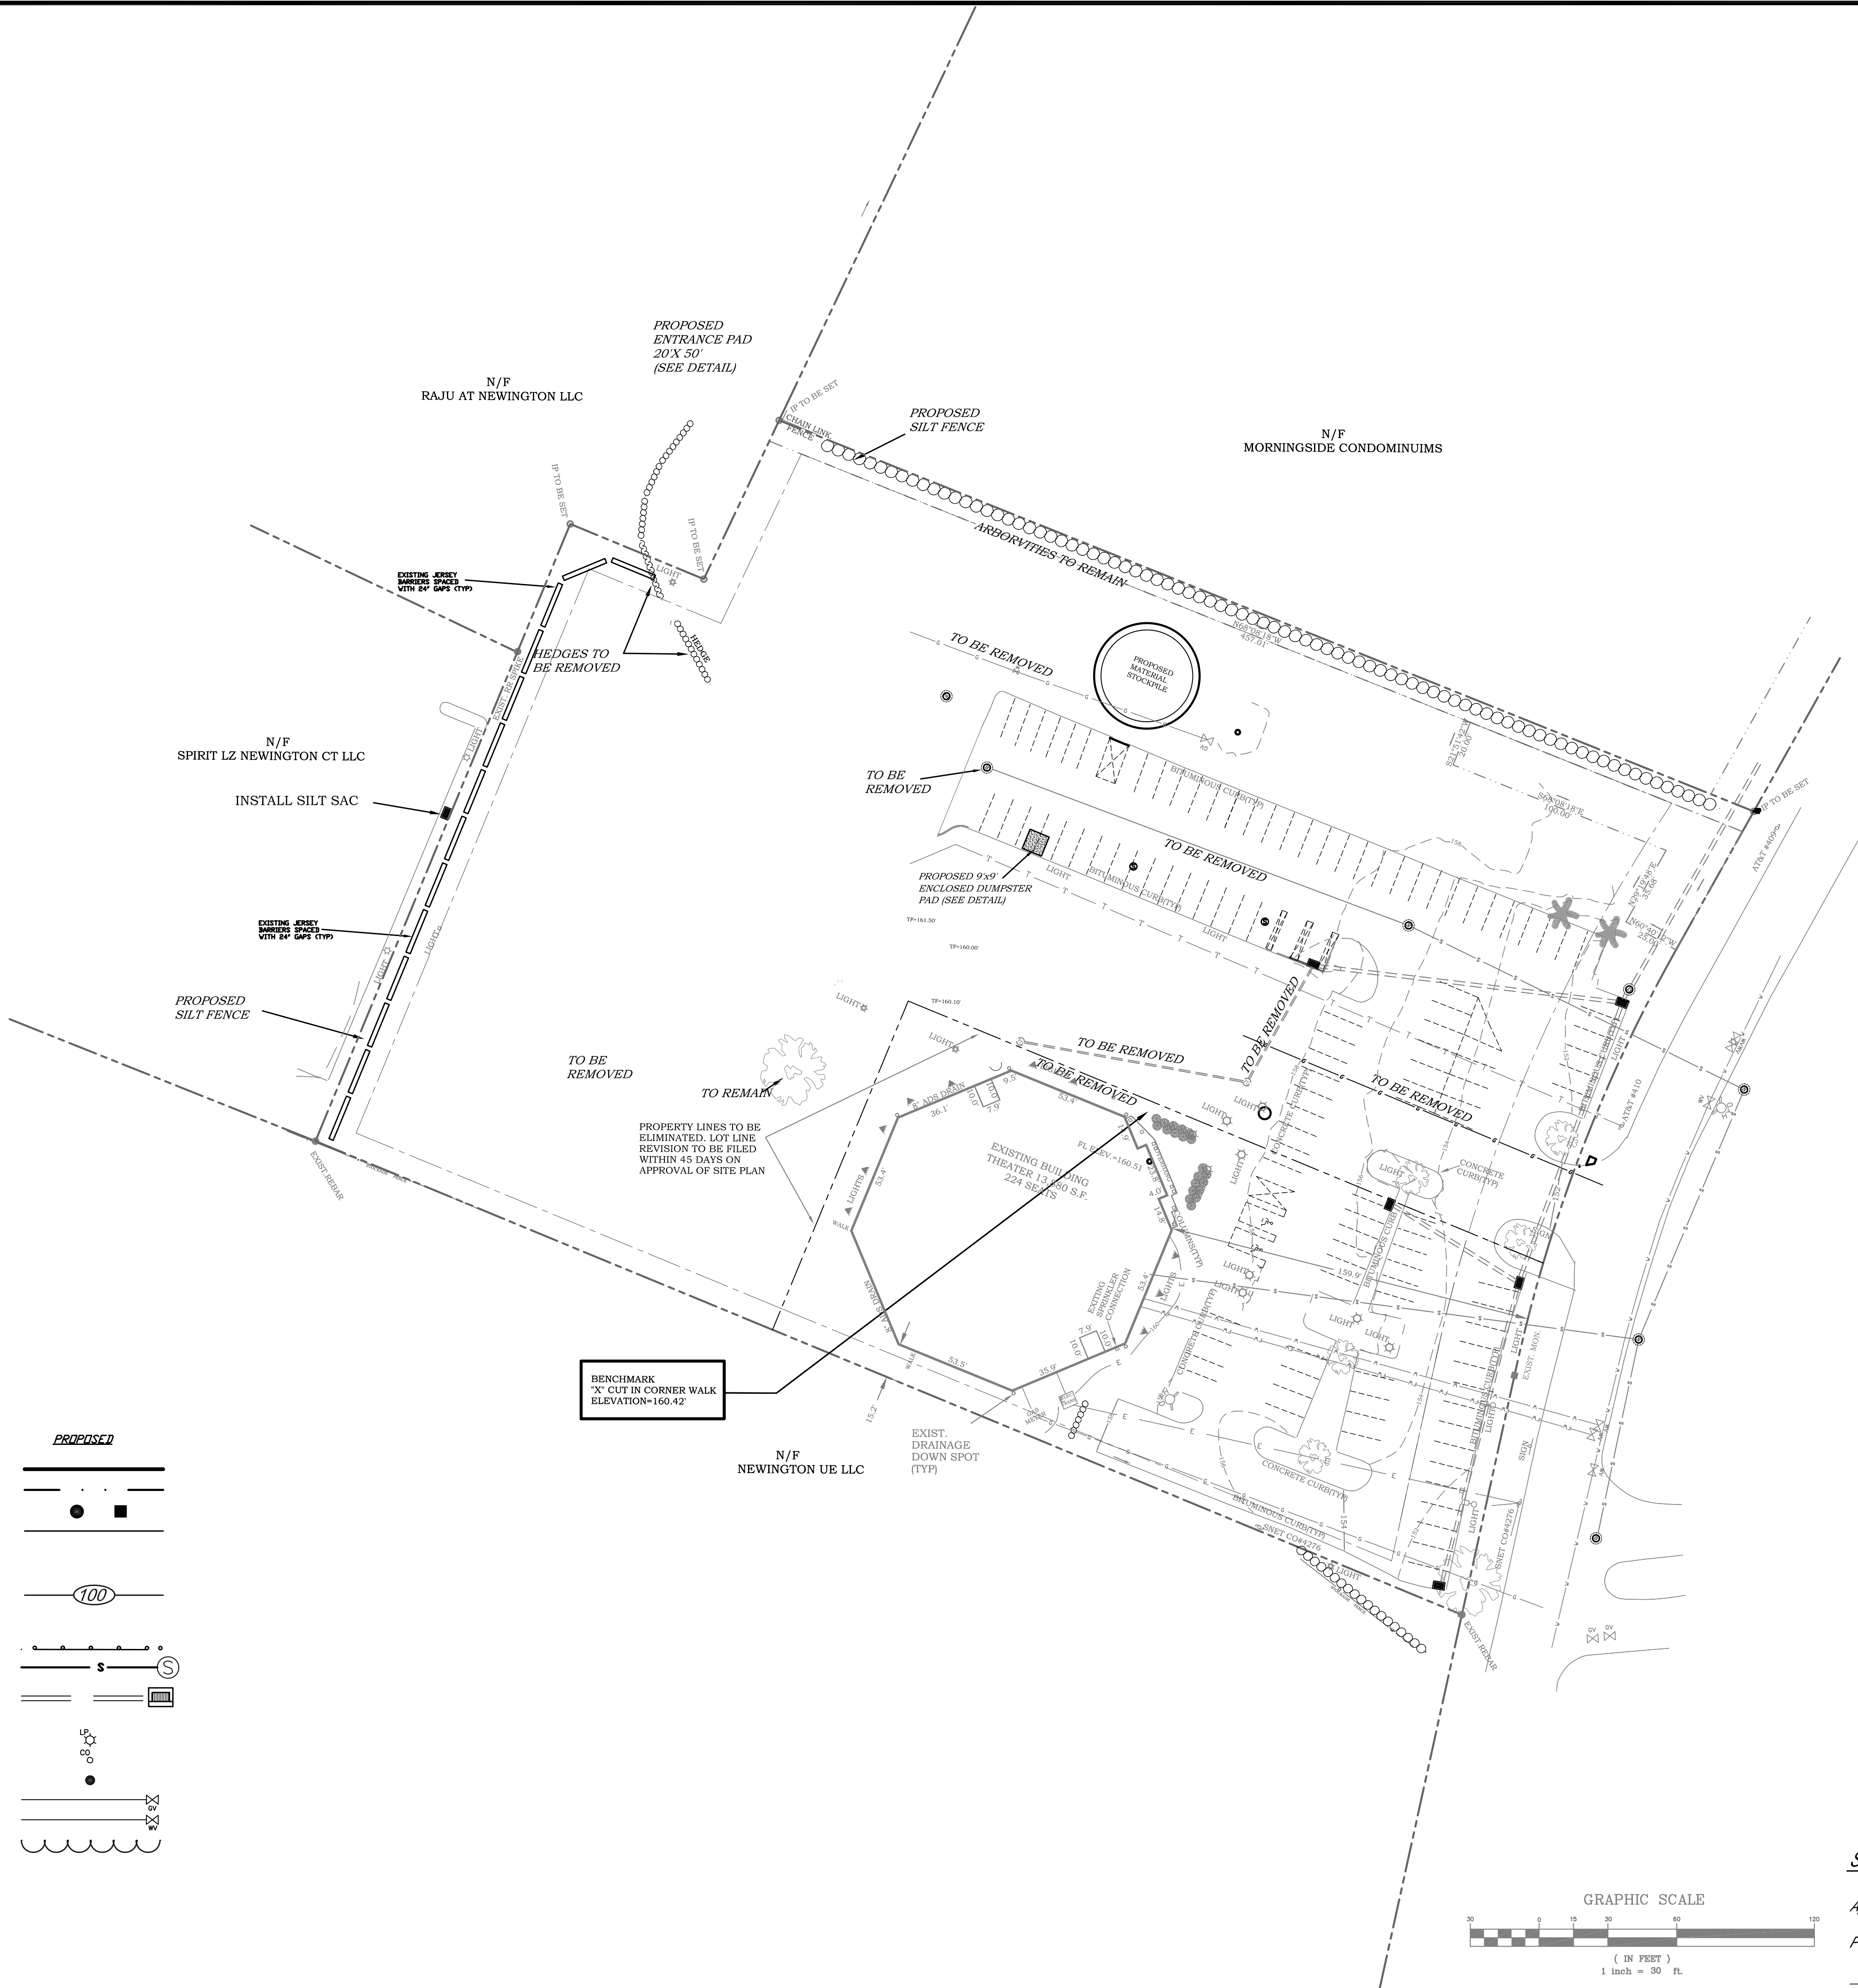

DEMO NOTES:

1. Notify the municipalities Planning and Engineering Departments of ensuing demo activity.
2. Install orange construction fence around site as shown on plan.
2. Establish erosion and sedimentation control measures, as shown in the plan prior to initiating any demo activity.
4. Call Before You Dig 1 800 922 4455.
5. Clear and grub site, trees and stumps shall be disposed of in an approved manner. Develop Construction Erosion.
6. Stop and stockpile topsoil; anchor with straw mulch and siltfence. If stockpiles are to be left in place for more than 45 days, they should be seeded with annual ryegrass at a rate of 40 lbs/acre.
7. Start mass demo work, buildings, concrete, pavement, lights, etc. unless otherwise noted.
8. Finish grade site, spread topsoil and seed all areas disturbed by construction. Stabilize all slopes.
9. Remove sediment and dispose of offsite in an environmentally acceptable manner.
10. After disturbed areas have had vegetation re-established on them, siltation barriers shall be removed.

DISPOSE OF ALL DEMO MATERIAL IN AN ENVIRONMENTALLY SAVE MANNOR

SIGNATURE BLOCK

Approved by the Town Plan and Zoning Commission under

Petition # _____ at meeting of _____

Date _____ Chairman _____

FILE NUMBER
223186

SHEET NUMBER
DEMO 1



Know what's below.
Call before you dig.

ENGINEER'S SEAL

NOT VALID UNLESS
EMPOWERED SEAL IS
AFFIXED HEREON.
Frank J. Cahill
FRANK J. CAHILL
CT. PEL #22988

REVISIONS:

DATE: 12/27/2024

DATE: 04/10/2025

DATE:

DATE:


DATE:

DATE:


DATE:

DATE:

DATE:

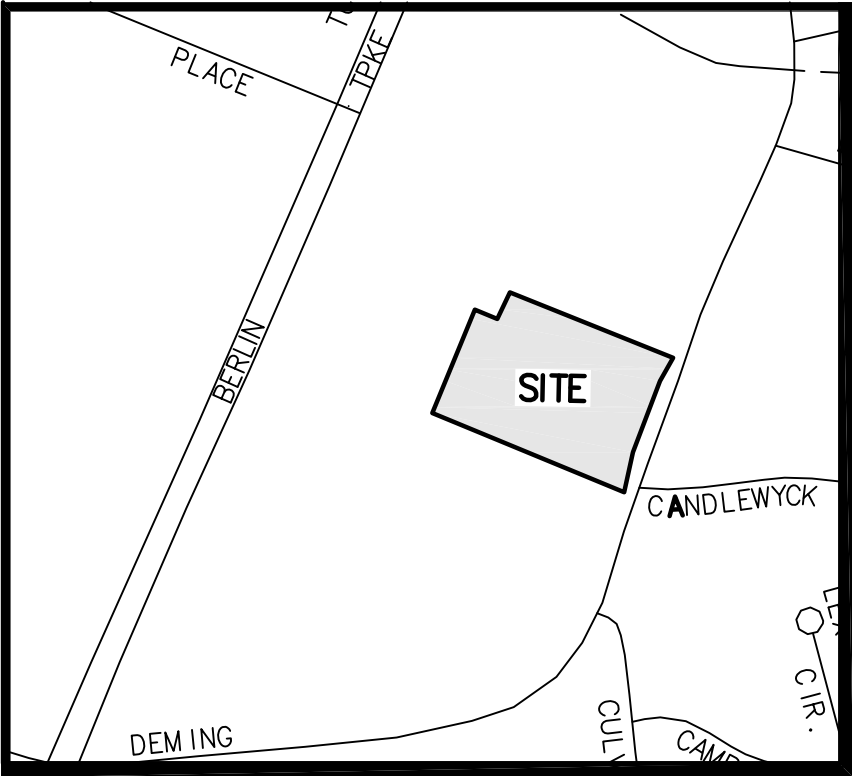

SITE LOCATION MAP
SCALE: 1"=500'


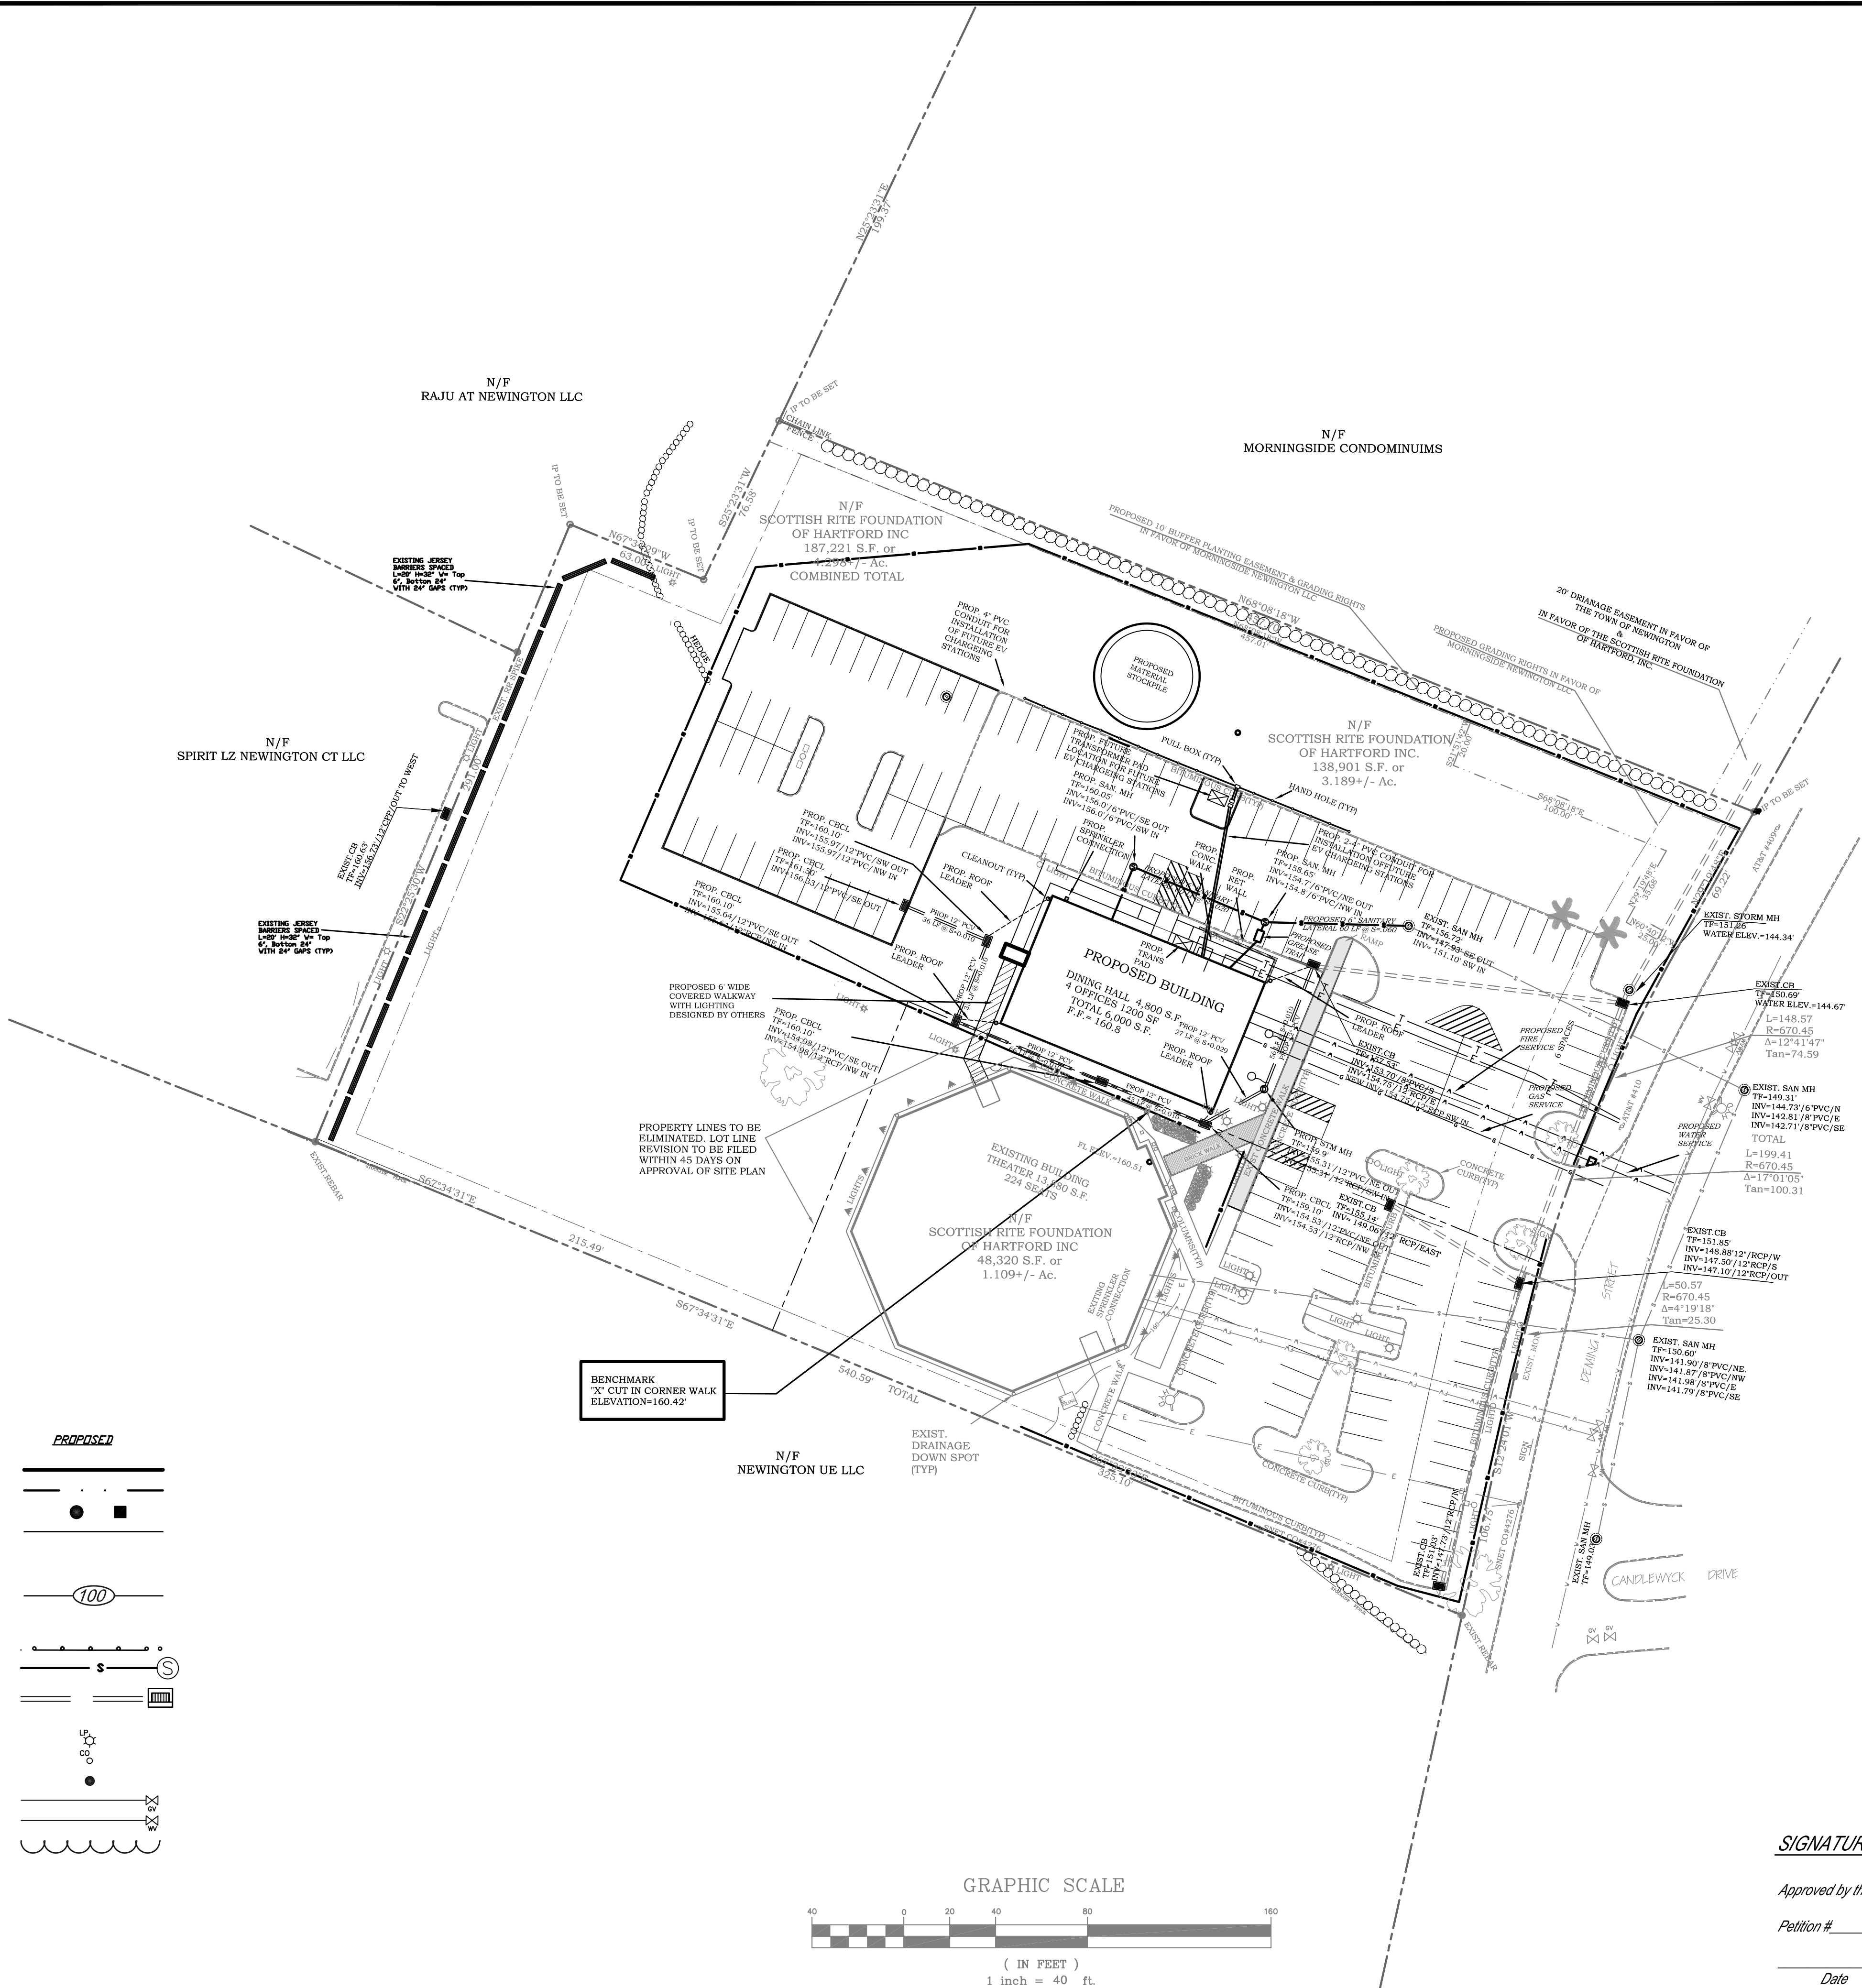


LEGEND


EXISTING

PROPOSED

- PROPERTY LINE
EASEMENT LINE
PINS/MINS
E.O.P.
WETLANDS
WETLANDS BUFFER
CONTOUR
STREAM
CHAIN LINK FENCE
GUARD RAIL
SANITARY SEWER
STORM SEWER
UTILITY POLE
LIGHT POLE
SANITARY CLEAN OUT
BOLLARD
GAS VALVE
WATER VALVE
TIE LINE
TIE

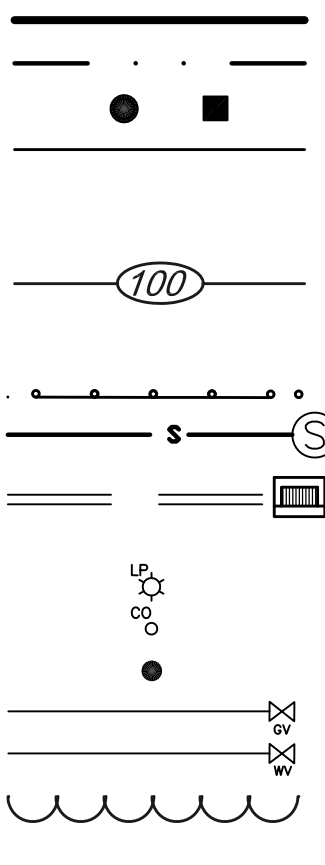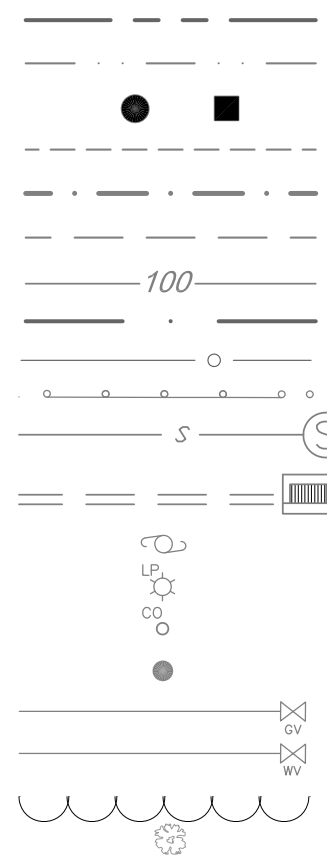

BENCHMARK
"X" CUT IN CORNER WALK
ELEVATION=160.42

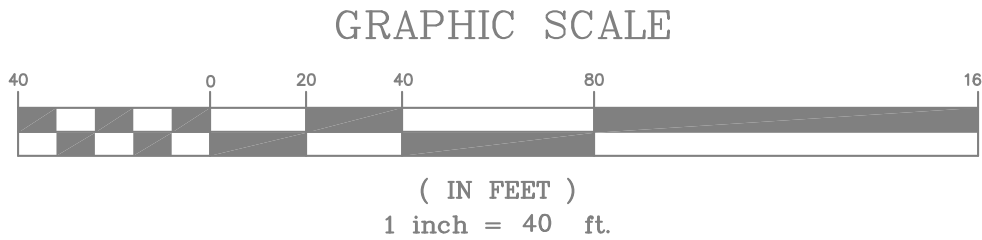

SIGNATURE BLOCK

Approved by the Town Plan and Zoning Commission under
Petition # _____ at meeting of _____

Date _____ Chairman _____



Know what's below.
Call before you dig.

THESE DRAWINGS ARE INSTRUMENTS OF PROFESSIONAL SERVICE OF JONES ENGINEERING LLC, AND HAVE BEEN PREPARED SPECIFICALLY FOR THE OWNER OF THIS PROJECT AT THIS SITE, AND ARE NOT TO BE USED FOR ANY OTHER PURPOSE, LOCATION OR OWNER WITHOUT WRITTEN CONSENT OF JONES ENGINEERING LLC.

SITE PLAN REVISION

5

UTILITY PLAN
PREPARED FOR
SCOTTISH RITE FOUNDATION
OF HARTFORD, INC.
#207 DEMING STREET
NEWINGTON, CONNECTICUT

JONES ENGINEERING LLC
CIVIL ENGINEERING & LAND SURVEYING
92 NORTH SUMMIT ST., SUITE 2A
P.O. BOX 249
SOUTHINGTON, CT 06489
PHONE: (860) 621-0700
FAX: (860) 621-6066

REVISIONS:
DATE: 12/27/2024
DATE: 04/10/2025
DATE: 05/06/2025
DATE: _____
DATE: _____
DATE: _____


ENGINEER'S SEAL
NOT VALID UNLESS
EMBOSSER SEAL IS
AFFIXED HEREON.
Frank J. Cahill
FRANK J. CAHILL
CT. PEL #22898

TO MY KNOWLEDGE AND BELIEF, THIS MAP IS
SUBSTANTIALLY CORRECT AS NOTED HEREON.
NOT VALID UNLESS
EMBOSSER SEAL IS
AFFIXED HEREON.
JAMES E. JONES CT. L.S. REG. NO. 12329 DATE _____

FILE NUMBER	SHEET NUMBER
223186	UTIL 1



Know what's below.
Call before you dig.

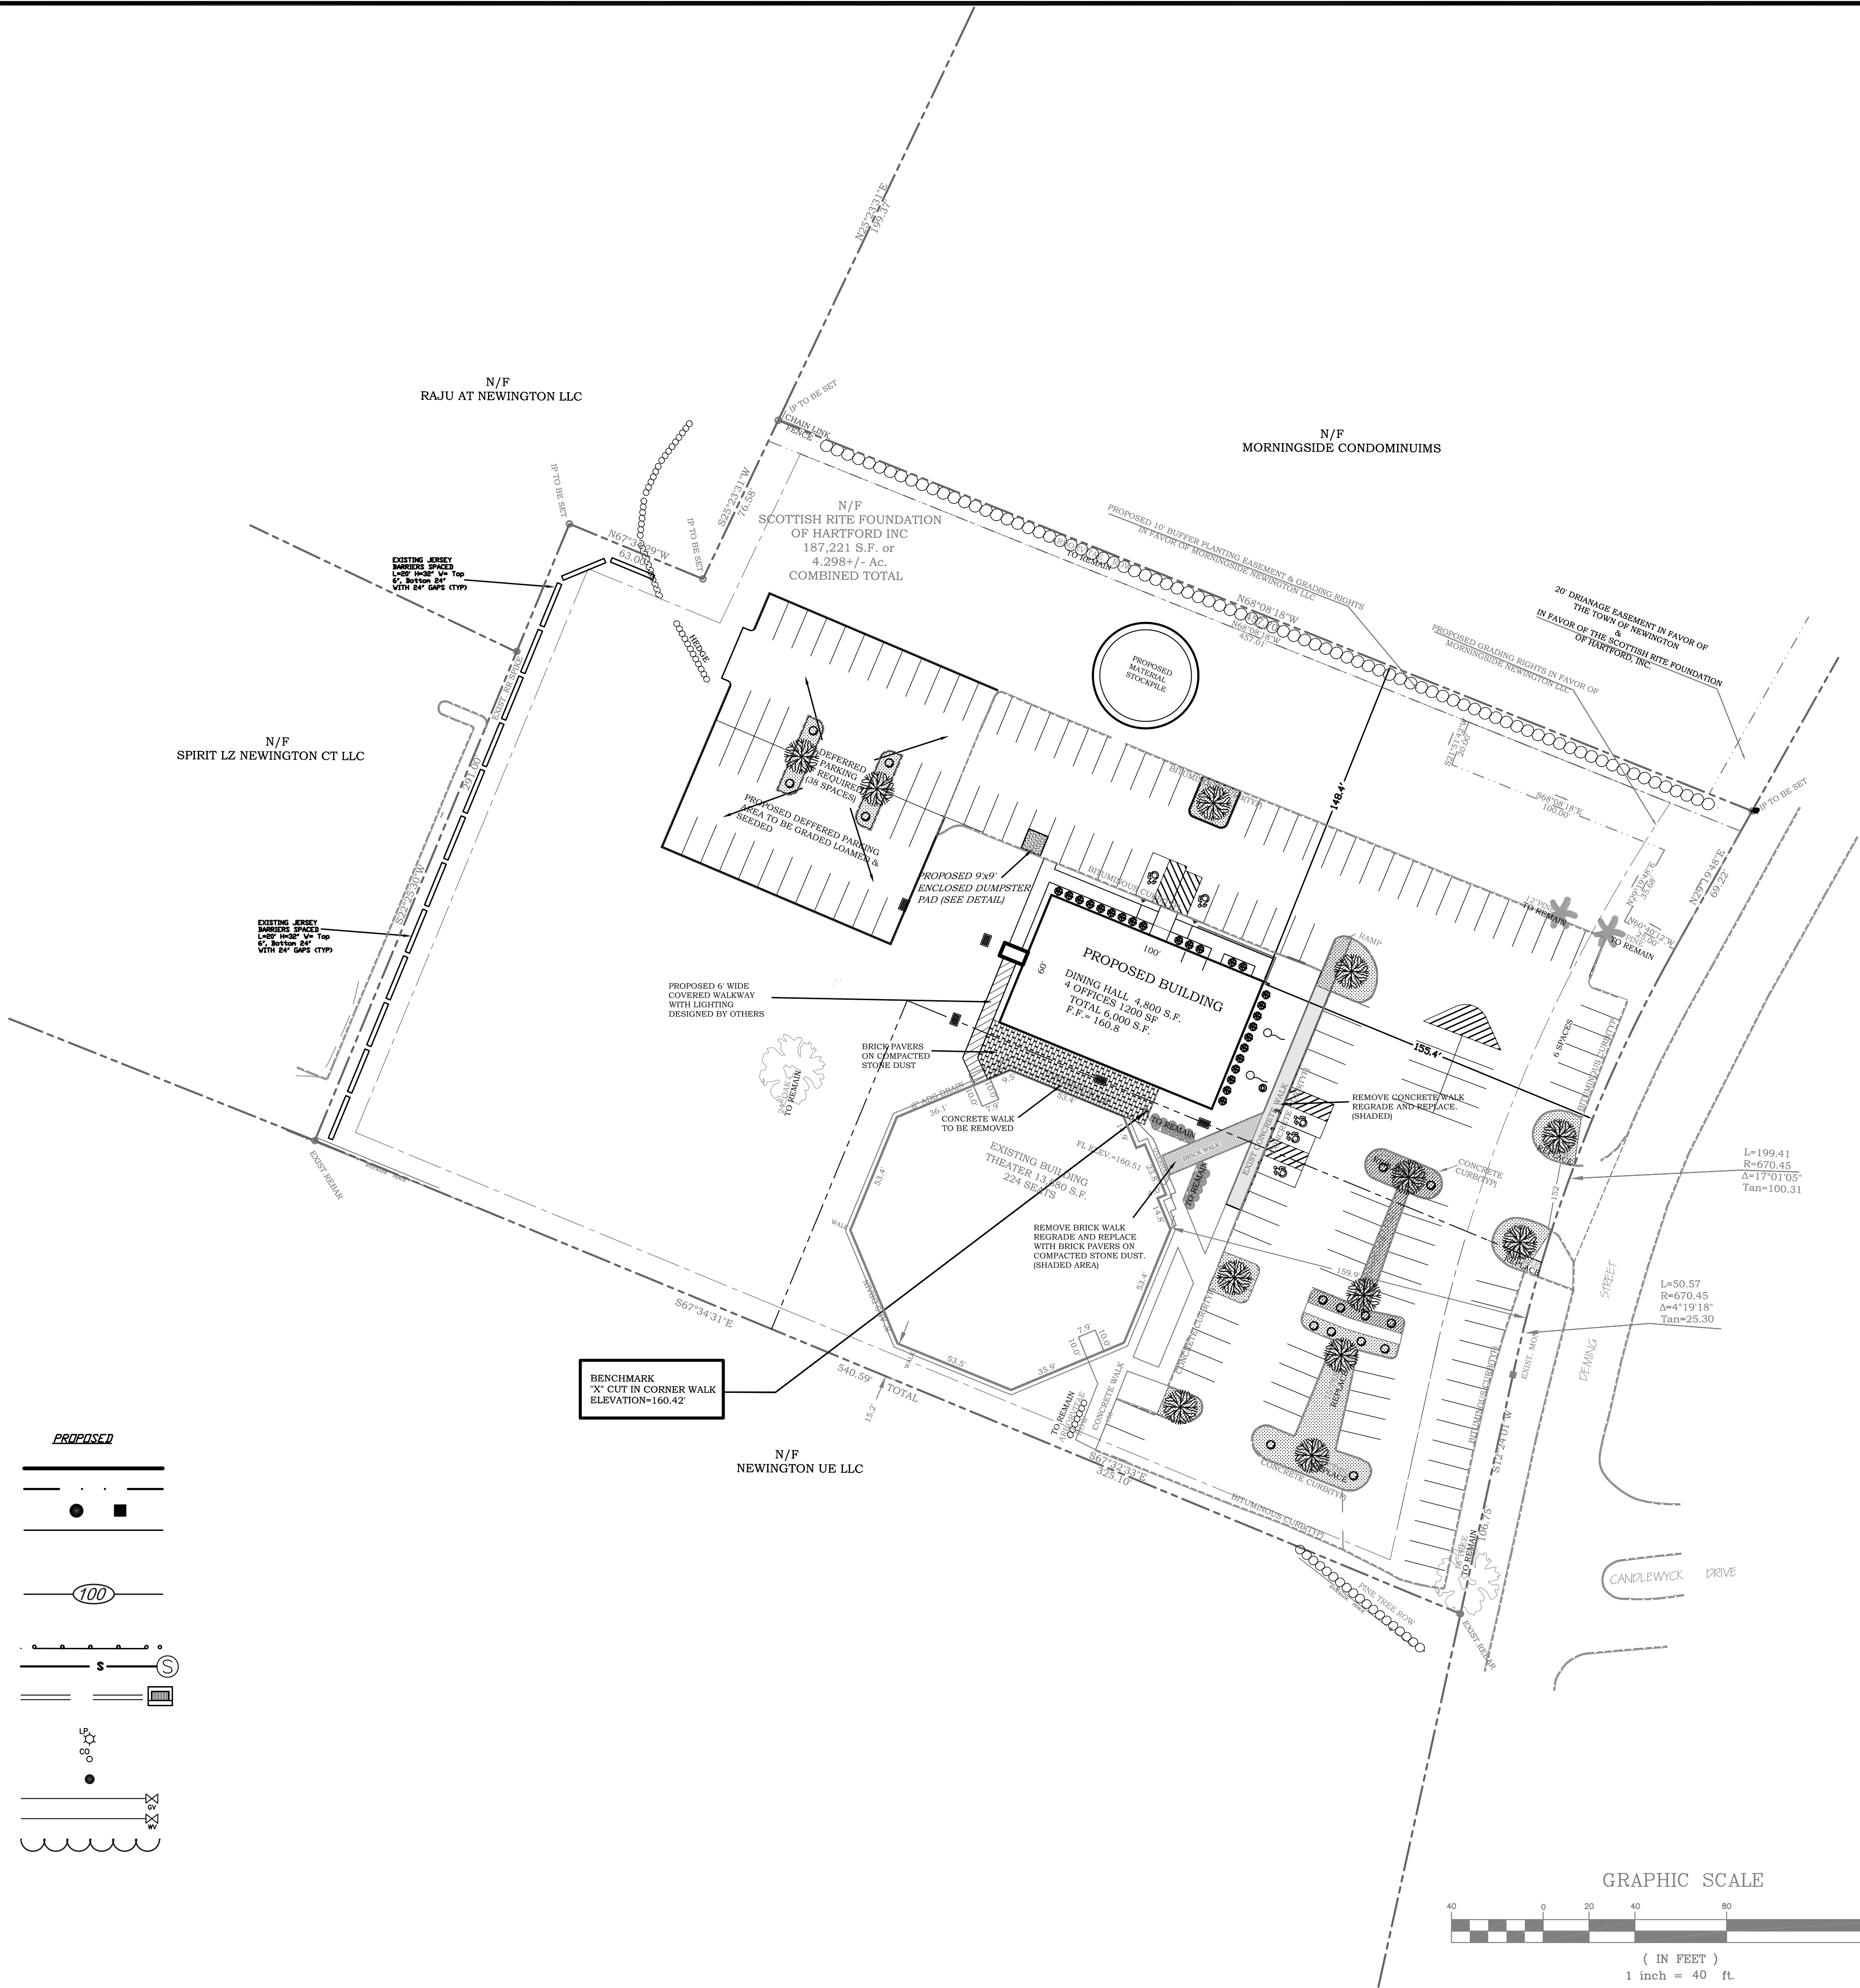

PLANTING SCHEDULE			
SPECIES	SIZE	TOTAL QUANT.	DEFERRED QUANT.
RED SUNSET MAPLE	2 1/2" DIA	12	2
PURPLE GEM RODADENDRUM	15-18"	25	4
RED RUFFLES AZALEA	15-18"	16	16

LEGEND


EXISTING	PROPOSED
PROPERTY LINE	PROPERTY LINE
EASEMENT LINE	EASEMENT LINE
PINS/MINS	PINS/MINS
EDP	EDP
WETLANDS	WETLANDS
WETLANDS BUFFER	WETLANDS BUFFER
CONTOUR	CONTOUR
STREAM	STREAM
CHAIN LINK FENCE	CHAIN LINK FENCE
GUARD RAIL	GUARD RAIL
SANITARY SEWER	SANITARY SEWER
STORM SEWER	STORM SEWER
UTILITY POLE	UTILITY POLE
LIGHT POLE	LIGHT POLE
SANITARY CLEAN OUT	SANITARY CLEAN OUT
BOLLARD	BOLLARD
GAS VALVE	GAS VALVE
WATER VALVE	WATER VALVE
TREELINE	TREELINE
TREE	TREE

THESE DRAWINGS ARE INSTRUMENTS OF PROFESSIONAL SERVICE OF JONES ENGINEERING LLC, AND HAVE BEEN PREPARED SPECIFICALLY FOR THE OWNER OF THIS PROJECT AT THIS SITE, AND ARE NOT TO BE USED FOR ANY OTHER PURPOSE, LOCATION OR OWNER WITHOUT WRITTEN CONSENT OF JONES ENGINEERING LLC.

SIGNATURE BLOCK

Approved by the Town Plan and Zoning Commission under
Petition # _____ at meeting of _____

Date _____ Chairman _____

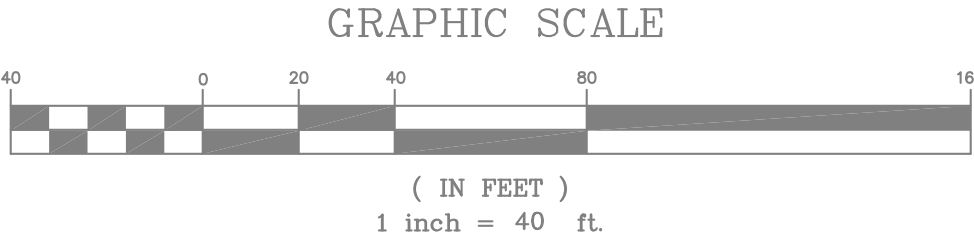

SITE PLAN REVISION

7

LANDSCAPE PLAN
PREPARED FOR
SCOTTISH RITE FOUNDATION
OF HARTFORD, INC.
207 DEMING STREET
NEWINGTON, CONNECTICUT


JONES ENGINEERING LLC
CIVIL ENGINEERING & LAND SURVEYING
92 NORTH SUMMIT ST., SUITE 2A
P.O. BOX 249
SOUTHINGTON, CT 06489
PHONE: (860) 621-0700
FAX: (860) 621-6066

SCALE: 1"=40'
DATE: 1/12/2024
DRAWN BY: RBB
CHECKED BY: JEE


REVISIONS:	
DATE: 12/27/2024	DATE: 04/10/2025
DATE: 04/10/2025	DATE: 05/06/2025
DATE: 05/06/2025	DATE: 05/06/2025
DATE: 05/06/2025	DATE: 05/06/2025
DATE: 05/06/2025	DATE: 05/06/2025
DATE: 05/06/2025	DATE: 05/06/2025

FILE NUMBER	SHEET NUMBER
223186	LS 1

JONES ENGINEERING LLC

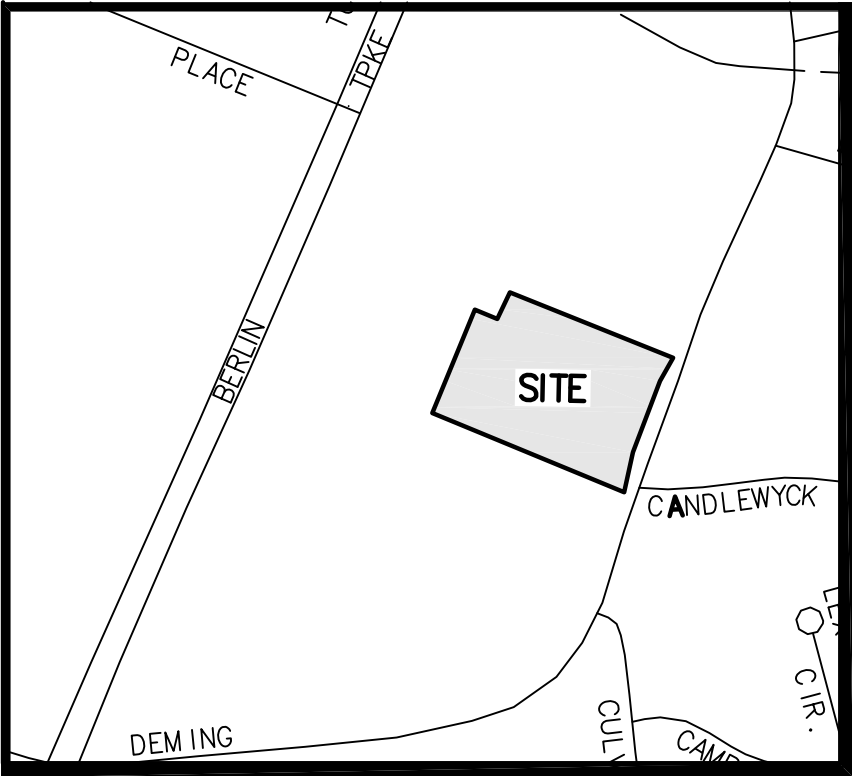

SITE LOCATION MAP
SCALE: 1"=500'


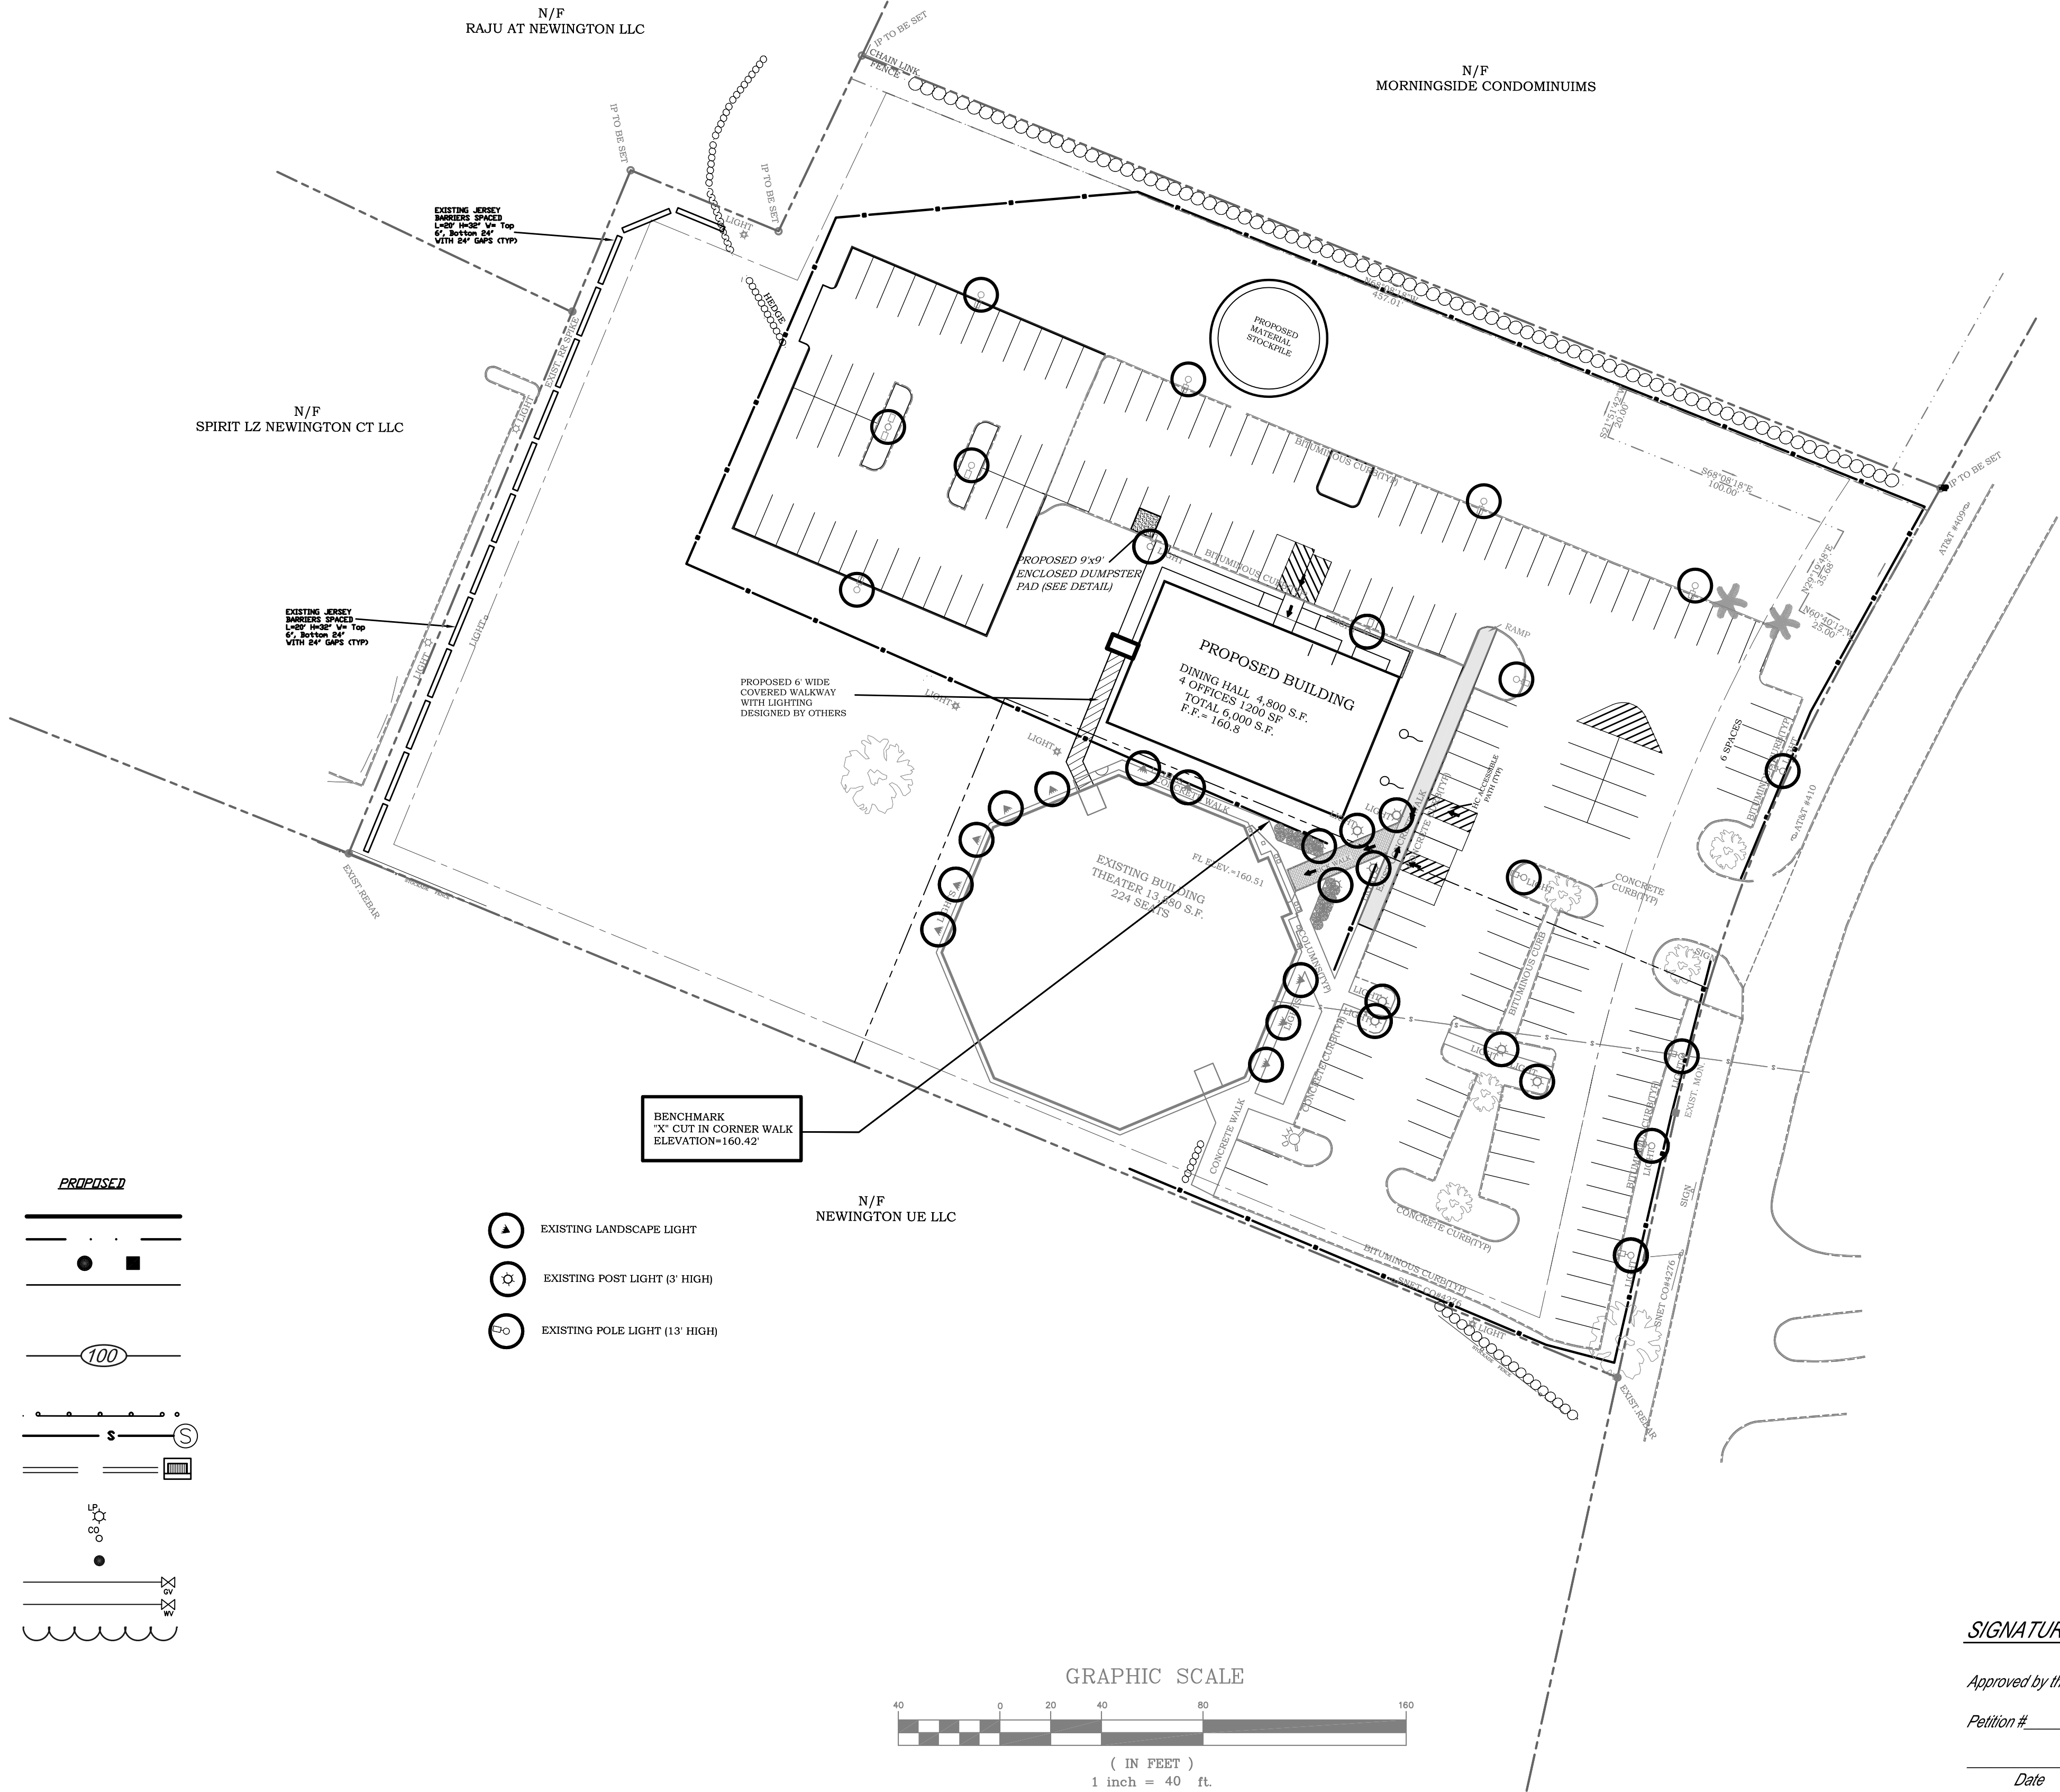


LEGEND

EXISTING


PROPOSED

PROPERTY LINE
EASEMENT LINE
PINS/MINS
E.O.P.
WETLANDS
WETLANDS BUFFER
CONTOUR
STREAM
CHAIN LINK FENCE
GUARD RAIL
SANITARY SEWER
STORM SEWER
UTILITY POLE
LIGHT POLE
SANITARY CLEAN OUT
BOLLARD
GAS VALVE
WATER VALVE
TRAIL LINE
TRAIL

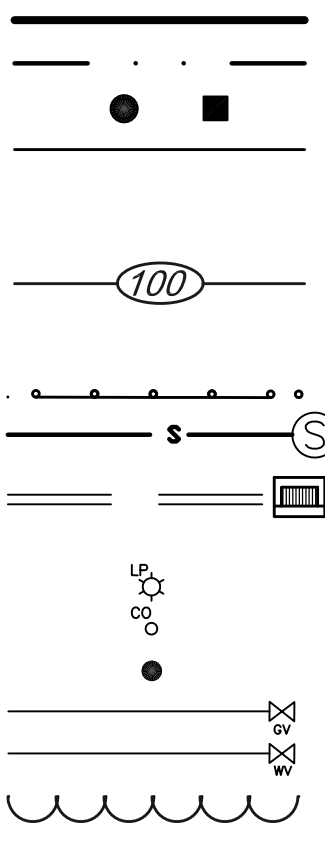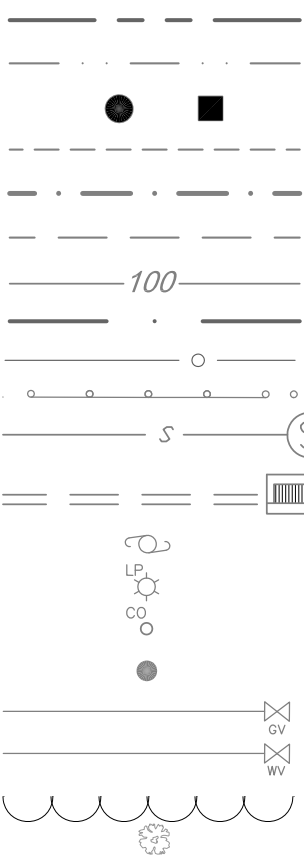

- EXISTING LANDSCAPE LIGHT
- EXISTING POST LIGHT (3' HIGH)
- EXISTING POLE LIGHT (13' HIGH)

GRAPHIC SCALE

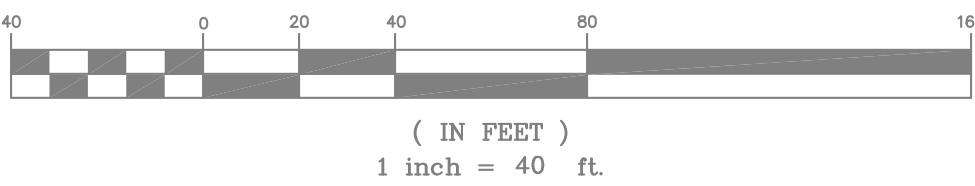

SEE MANUFACTURER'S ILLUMINATION
PLAN AND DETAILS

SIGNATURE BLOCK

Approved by the Town Plan and Zoning Commission under
Petition # _____ at meeting of _____

Date _____ Chairman _____

FILE NUMBER
223186

SHEET NUMBER
LIGHT 1



Know what's below.
Call before you dig.

THESE DRAWINGS ARE INSTRUMENTS OF PROFESSIONAL SERVICE OF JONES ENGINEERING LLC, AND HAVE BEEN PREPARED SPECIFICALLY FOR THE OWNER OF THIS PROJECT AT THIS SITE, AND ARE NOT TO BE USED FOR ANY OTHER PURPOSE, LOCATION OR OWNER WITHOUT WRITTEN CONSENT OF JONES ENGINEERING LLC.


LIGHTING PLAN
PREPARED FOR
SCOTTISH RITE FOUNDATION
OF HARTFORD, INC.
#207 DEMING STREET
NEWINGTON, CONNECTICUT

JONES
ENGINEERING LLC
CIVIL ENGINEERING & LAND SURVEYING
92 NORTH SUMMIT ST., SUITE 2A
P.O. BOX 249
SOUTHINGTON, CT 06489
PHONE: (860) 621-0700
FAX: (860) 621-6066

SCALE: 1"=40'
DATE: 1/12/2024
DRAWN BY: RBB
CHECKED BY: JEJ

ENGINEER'S SEAL
NOT VALID UNLESS
EMBOSSER SEAL IS
AFFIXED HEREON
Frank J. Cahill
FRANK J. CAHILL
CT. PEL #22898

TO MY KNOWLEDGE AND BELIEF, THIS MAP IS
SUBSTANTIALLY CORRECT AS NOTED HEREON.
NOT VALID UNLESS
EMBOSSER SEAL IS
AFFIXED HEREON.
JAMES E. JONES CT. L.S. REG. NO. 12329 DATE _____

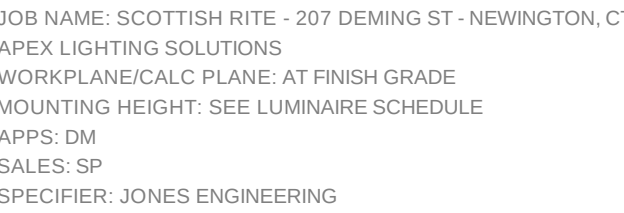


Luminaire Schedule							
Qty	Label	Arrangement	Lumens	Input Watts	LLF	BUG Rating	Description
4	SL2	Single	5725	38.14286	0.900	B2-U0-G2	GARDCO OPF-S-P03-830-T2M-VOLT-FINISH-OPF-RMB / MOUNTED TO 13FT POLE
2	SL3A	Single	5783	38.14286	0.900	B2-U0-G2	GARDCO OPF-S-P03-830-T3M-VOLT-FINISH-OPF-RMB / MOUNTED TO EXISTING 13FT POLE
2	SL3C	Back-Back	5783	38.14286	0.900	B2-U0-G2	GARDCO OPF-S-P03-830-T3M-VOLT-FINISH-OPF-RMB / MOUNTED TO EXISTING 13FT POLE
1	SL4A	Single	5669	38.14286	0.900	B1-U0-G2	GARDCO OPF-S-P03-830-T4M-VOLT-FINISH-OPF-RMB / MOUNTED TO EXISTING 13FT POLE
4	SL4S	Single	5669	38.14286	0.900	B1-U0-G2	GARDCO OPF-S-P03-830-T4M-VOLT-FINISH-OPF-S-EHS-1-OPF-RMB / MOUNTED TO EXISTING 13FT POLE / SHIELD NOT SHOWN IN CALC
2	SL5A	Single	5552	38.14286	0.900	B3-U0-G1	GARDCO OPF-S-P03-830-T5M-VOLT-FINISH-OPF-RMB / MOUNTED TO EXISTING 13FT POLE
2	SL5B	Single	5552	38.14286	0.900	B3-U0-G1	GARDCO OPF-S-P03-830-T5M-VOLT-FINISH-OPF-RMB / MOUNTED TO 13FT POLE

Calculation Summary						
Label	Grid Height	Avg	Max	Min	Avg/Min	Max/Min
PARKING AND DRIVE LANES	0	1.23	5.8	0.0	N.A.	N.A.
SITE	0	0.34	7.6	0.0	N.A.	N.A.

Calculations have been performed according to IES standards and good practice. Some differences between measured values and calculated results may occur due to tolerances in calculation methods, testing procedures, component performance, measurement techniques and field conditions such as voltage and temperature variations. Input data used to generate the attached calculations such as room dimensions, reflectances, furniture and architectural elements significantly affect the lighting calculations. If the real environment conditions do not match the input data, differences will occur between measured values and calculated values.

Total Light Loss Factor (LLF) applied at time of design is determined by applying the Lamp Lumen Depreciation (LLD) from current lamp manufacturer's catalog, a Luminaire Dirt Depreciation Factor (LDD) based on IES recommended values and a Ballast Factor (BF) from current ballast specification sheets. Application of an incorrect Light Loss Factor (LLF) will result in forecasts of performance that will not accurately depict actual results.

 For proper comparison of photometric layouts, it is essential that you insist all designers use correct Light Loss Factors.



20-30 BEAVER ROAD, WETHERSFIELD, CT 06109
TELEPHONE 860.632.8766 / WWW.APEXLTG.COM

SCOTTISH RITE
207 DEMING ST
NEWINGTON, CT

DATE: 4/28/25

SITE LIGHTING PHOTOMETRIC CALCULATION

DRAWN BY: DM

SHEET:

SL-2F